

240V SUPPLY SPURS
FED FROM LOCAL DB

INVERTOR POSITION
No 1 SERVING SUB
CORE STAIRCASE

SWA CABLE DROPS
FROM HIGH LEVEL TO
FEED UNSWITCHED
FUSED CONNECTION
UNIT C.W NEON LIGHT
& FLEX OUTLET

INVERTOR UNIT FOR
EMERGENCY LIGHTING
LOCATED BELOW
EXISTING DATA
CABINET

FIRE EQUIPMENT

- FIRE ALARM CALL POINT/BREAK GLASS
- FIRE ALARM CONTROL PANEL
- FIRE ALARM INTERFACE PANEL
- UNSWITCHED FUSE SPUR
- JUNCTION BOX
- FIRE ALARM SOUNDER
- FIRE ALARM BELL
- VISUAL WARNING DEVICE

FIRE EXTINGUISHERS

- WATER EXTINGUISHER
- CARBON DIOXIDE EXTINGUISHER
- FOAM EXTINGUISHER
- POWDER EXTINGUISHER
- FIRE BLANKET

FIRE SIGNAGE

- FIRE EXIT SIGN
- FIRE EXIT DIRECTIONAL SIGN
- DOUBLE SIDED FIRE EXIT SIGN
- FIRE ACTION NOTICE
- ILLUMINATED FIRE EXIT SIGN

FIRE REFUGE

- REFUGE AREA
- REFUGE AREA WITH EVACUATION CHAIR
- EVACUATION CHAIR
- CALL ASSISTANCE POINT

DATE	DESCRIPTION	REV
		-




Campus Services
Pandon Building
Camden Street
Newcastle upon Tyne
NE1 8ST

Campus: CITY CENTRE
Building: LIBRARY
Title: SUB BASEMENT LEVEL


Scale:	Date: JULY 2019
NTS	Drawn:
	Issued:

Project No:

Drawing No:	Rev:
-------------	------

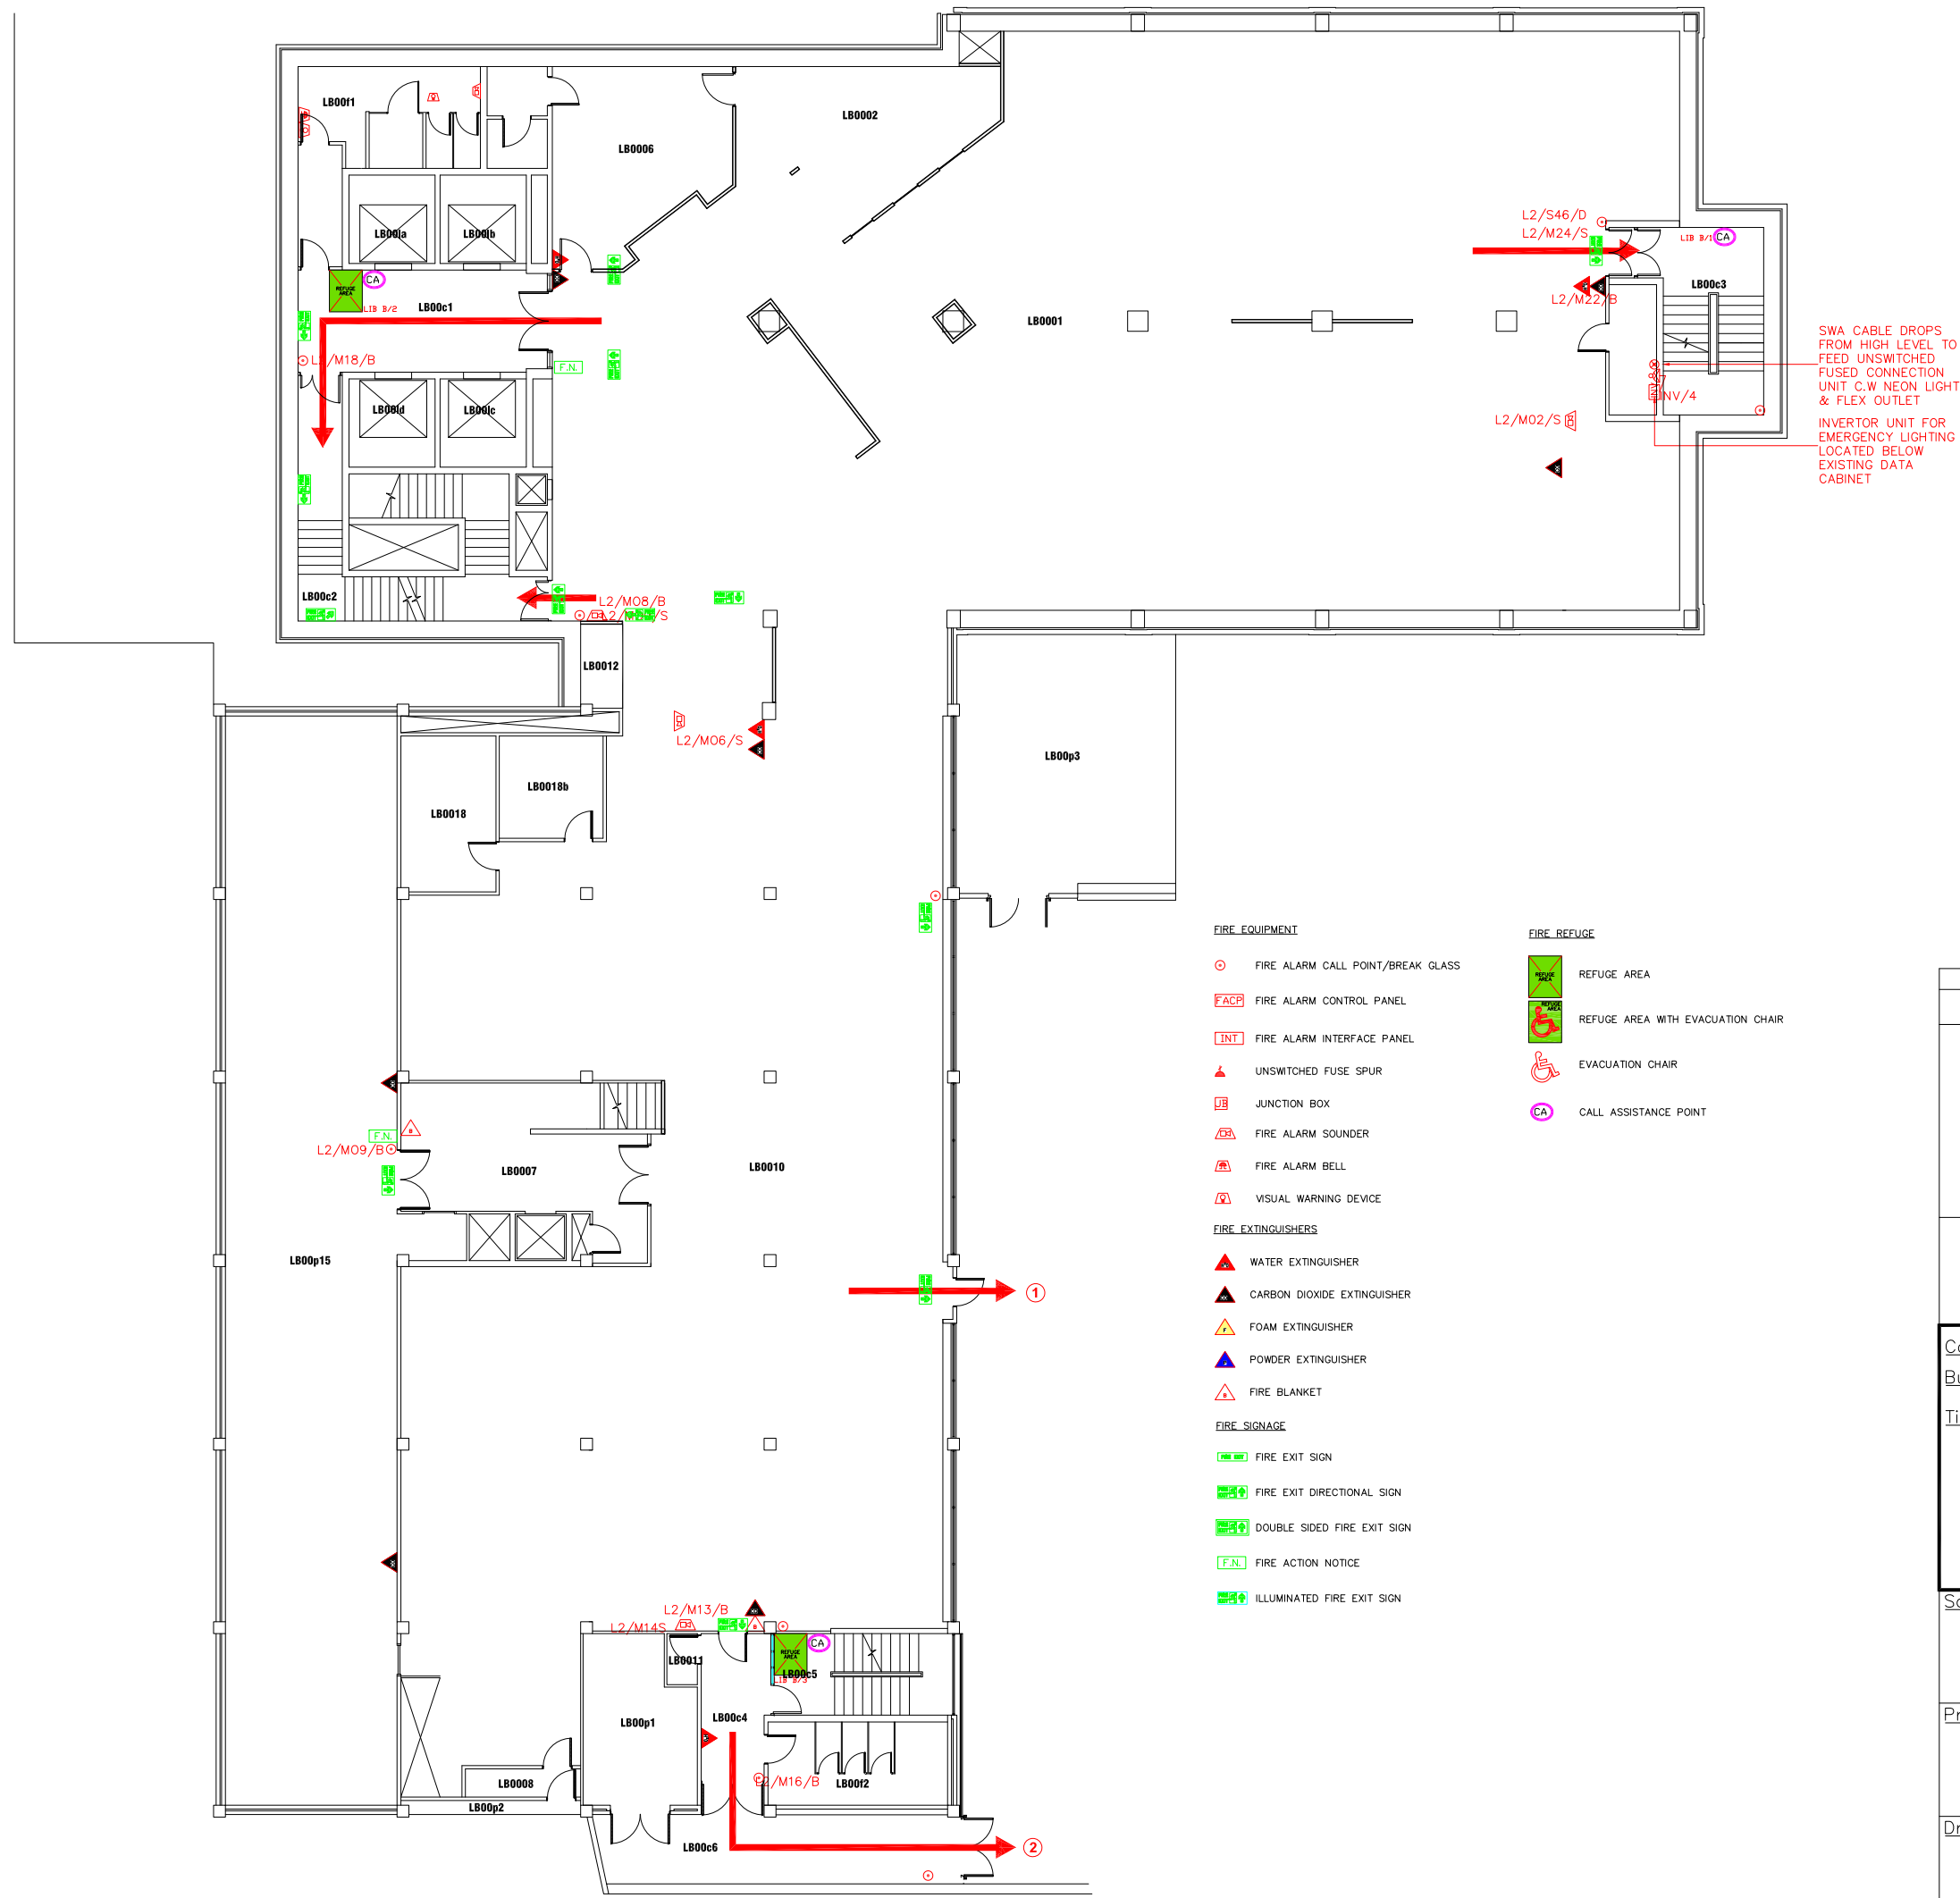

DATE	DESCRIPTION	REV
		-



Northumbria University
NEWCASTLE


Campus Services
Pandon Building
Camden Street
Newcastle upon Tyne
NE1 8ST

Campus: CITY CENTRE	
Building: LIBRARY	
Title: BASEMENT LEVEL	

Scale: NTS	Date: JULY 2019
	Drawn:
	Issued:


Project No:	
-------------	--

Drawing No:	Rev:
-------------	------

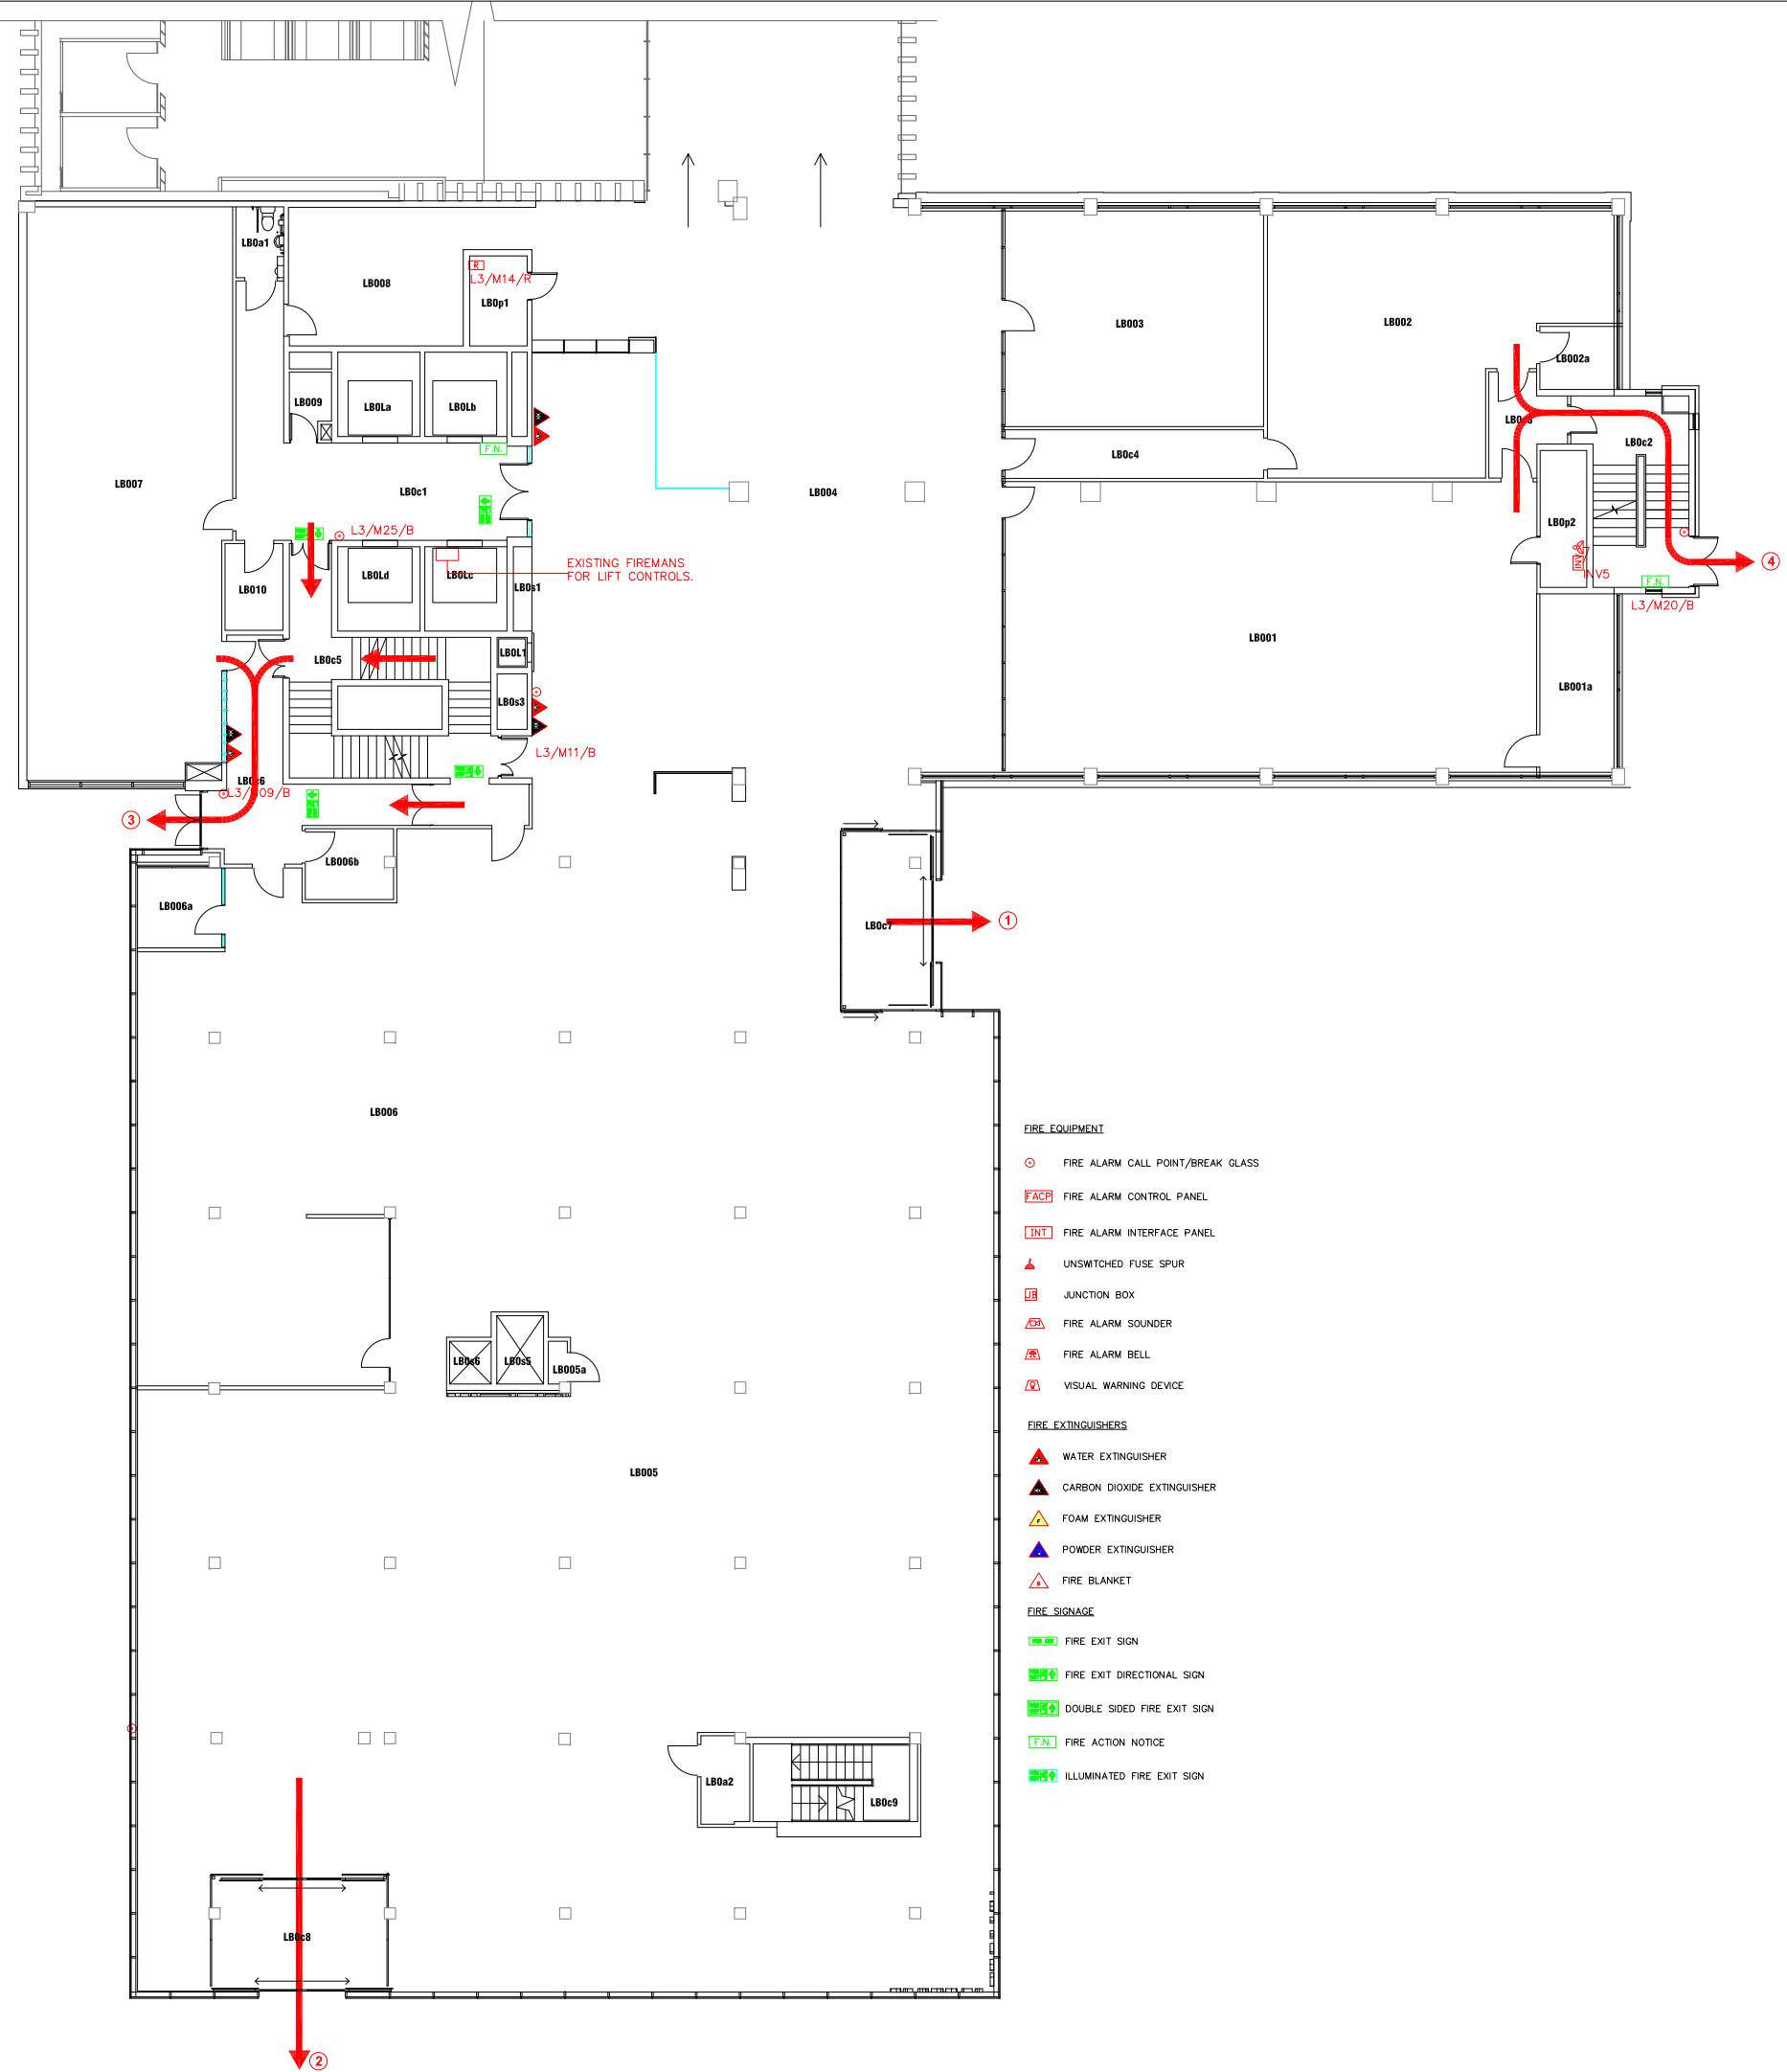

- FIRE EQUIPMENT**
- FIRE ALARM CALL POINT/BREAK GLASS
 - FIRE ALARM CONTROL PANEL
 - FIRE ALARM INTERFACE PANEL
 - UNSWITCHED FUSE SPUR
 - JUNCTION BOX
 - FIRE ALARM SOUNDER
 - FIRE ALARM BELL
 - VISUAL WARNING DEVICE
- FIRE EXTINGUISHERS**
- WATER EXTINGUISHER
 - CARBON DIOXIDE EXTINGUISHER
 - FOAM EXTINGUISHER
 - POWDER EXTINGUISHER
 - FIRE BLANKET
- FIRE SIGNAGE**
- FIRE EXIT SIGN
 - FIRE EXIT DIRECTIONAL SIGN
 - DOUBLE SIDED FIRE EXIT SIGN
 - FIRE ACTION NOTICE
 - ILLUMINATED FIRE EXIT SIGN

DATE	DESCRIPTION	REV
		-



Northumbria University
NEWCASTLE


Campus Services
 Pandon Building
 Camden Street
 Newcastle upon Tyne
 NE1 8ST

Campus: CITY CENTRE
 Building: LIBRARY
 Title: GROUND FLOOR LEVEL

Scale:	Date: JULY 2019
NTS	Drawn:
	Issued:

Project No:

Drawing No:	Rev:
-------------	------

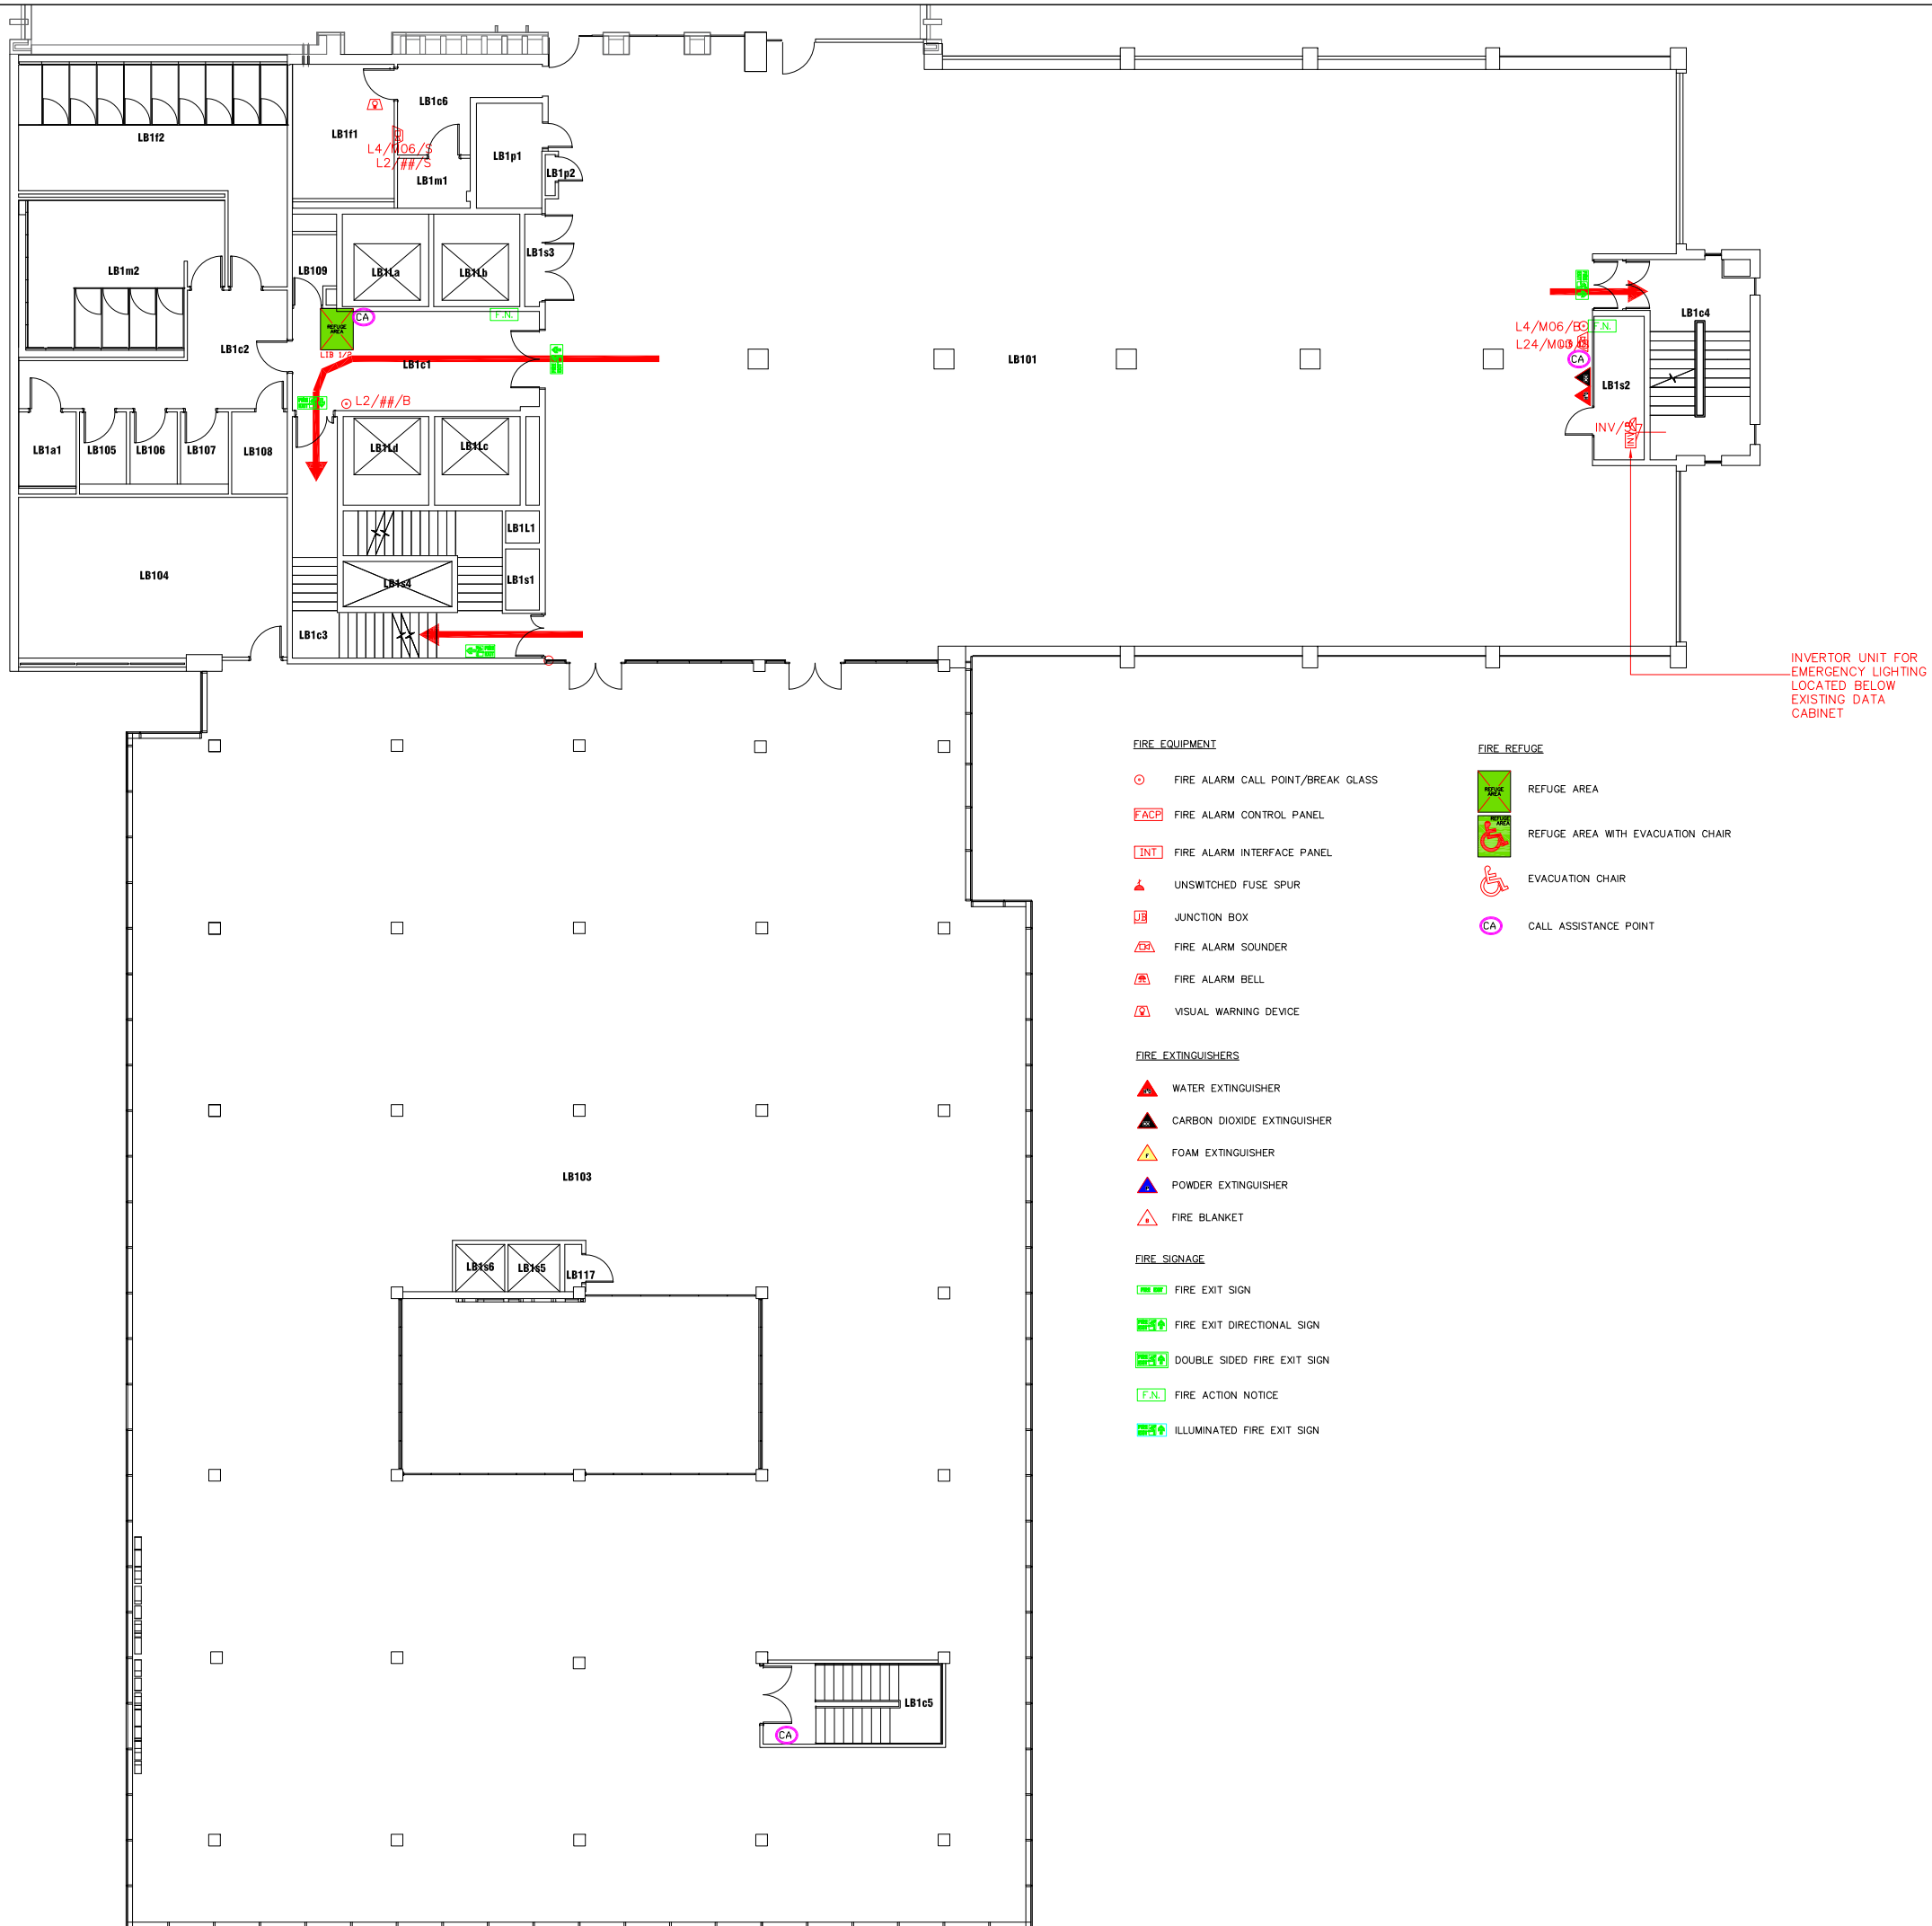

- FIRE EQUIPMENT**
- FIRE ALARM CALL POINT/BREAK GLASS
 - FIRE ALARM CONTROL PANEL
 - FIRE ALARM INTERFACE PANEL
 - UNSWITCHED FUSE SPUR
 - JUNCTION BOX
 - FIRE ALARM SOUNDER
 - FIRE ALARM BELL
 - VISUAL WARNING DEVICE
- FIRE EXTINGUISHERS**
- WATER EXTINGUISHER
 - CARBON DIOXIDE EXTINGUISHER
 - FOAM EXTINGUISHER
 - POWDER EXTINGUISHER
 - FIRE BLANKET
- FIRE SIGNAGE**
- FIRE EXIT SIGN
 - FIRE EXIT DIRECTIONAL SIGN
 - DOUBLE SIDED FIRE EXIT SIGN
 - FIRE ACTION NOTICE
 - ILLUMINATED FIRE EXIT SIGN
- FIRE REFUGE**
- REFUGE AREA
 - REFUGE AREA WITH EVACUATION CHAIR
 - EVACUATION CHAIR
 - CALL ASSISTANCE POINT

INVERTOR UNIT FOR EMERGENCY LIGHTING LOCATED BELOW EXISTING DATA CABINET

DATE	DESCRIPTION	REV
		-




Campus Services
Pandon Building
Camden Street
Newcastle upon Tyne
NE1 8ST

Campus: CITY CENTRE
Building: LIBRARY
Title: FIRST FLOOR LEVEL

Scale:	Date: JULY 2019
NTS	Drawn:
	Issued:

Project No:

Drawing No:	Rev:
-------------	------

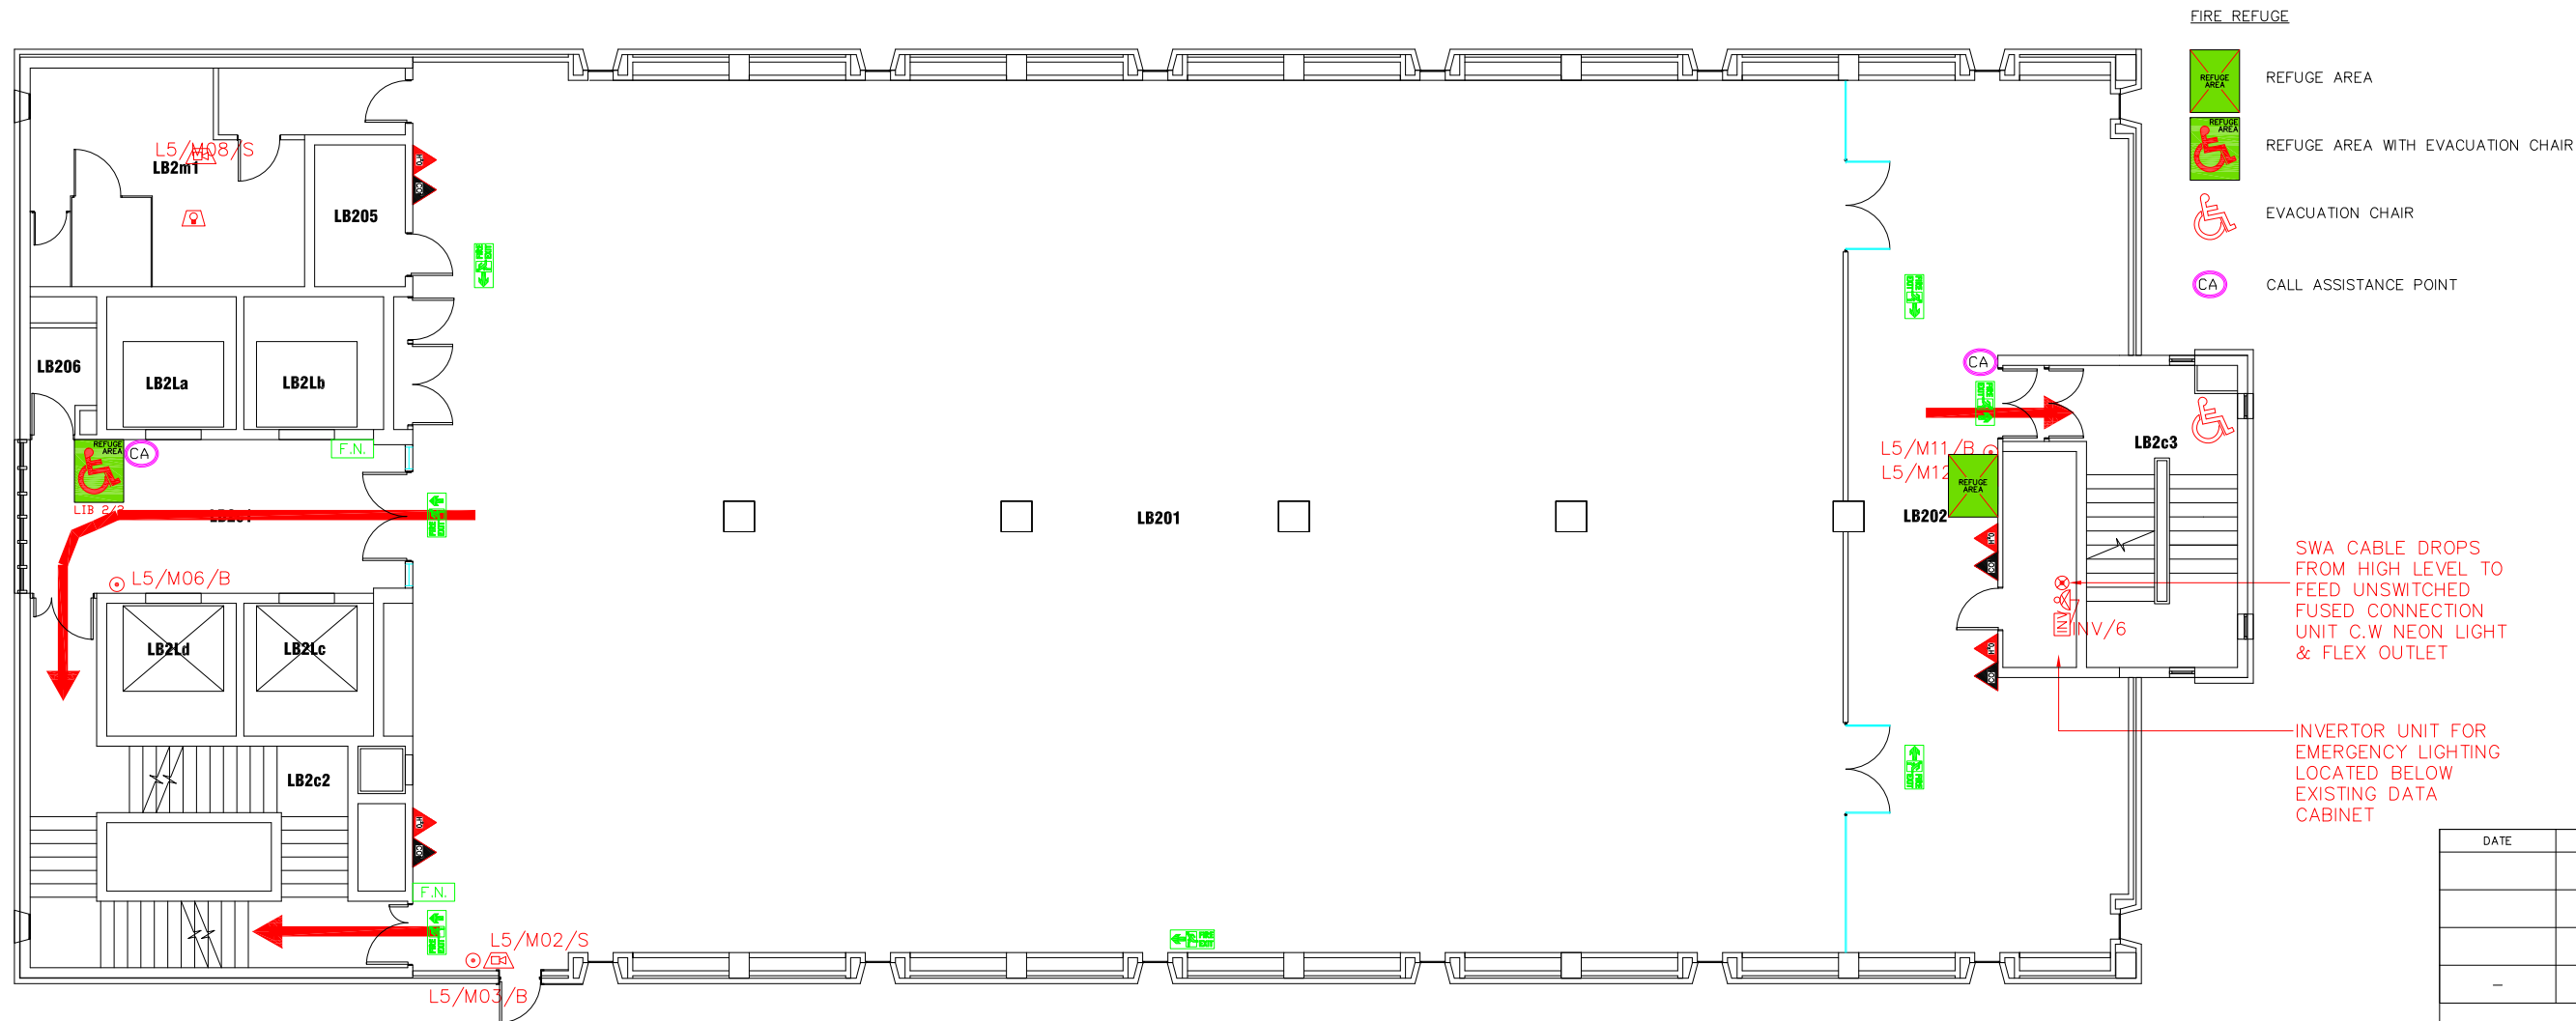

- FIRE REFUGE**
- REFUGE AREA
 - REFUGE AREA WITH EVACUATION CHAIR
 - EVACUATION CHAIR
 - CALL ASSISTANCE POINT

SWA CABLE DROPS FROM HIGH LEVEL TO FEED UNSWITCHED FUSED CONNECTION UNIT C.W NEON LIGHT & FLEX OUTLET

INVERTOR UNIT FOR EMERGENCY LIGHTING LOCATED BELOW EXISTING DATA CABINET

FIRE EQUIPMENT

- FIRE ALARM CALL POINT/BREAK GLASS
- FIRE ALARM CONTROL PANEL
- FIRE ALARM INTERFACE PANEL
- UNSWITCHED FUSE SPUR
- JUNCTION BOX
- FIRE ALARM SOUNDER
- FIRE ALARM BELL
- VISUAL WARNING DEVICE

FIRE EXTINGUISHERS

- WATER EXTINGUISHER
- CARBON DIOXIDE EXTINGUISHER
- FOAM EXTINGUISHER
- POWDER EXTINGUISHER
- FIRE BLANKET

FIRE SIGNAGE

- FIRE EXIT SIGN
- FIRE EXIT DIRECTIONAL SIGN
- DOUBLE SIDED FIRE EXIT SIGN
- FIRE ACTION NOTICE
- ILLUMINATED FIRE EXIT SIGN

DATE	DESCRIPTION	REV
		-
		-
		-
		-




Campus Services
Pandon Building
Camden Street
Newcastle upon Tyne
NE1 8ST

Campus: CITY CENTRE
Building: LIBRARY
Title: SECOND FLOOR LEVEL

Scale:	Date: JULY 2019
NTS	Drawn:
	Issued:

Project No:

Drawing No:	Rev:
-------------	------

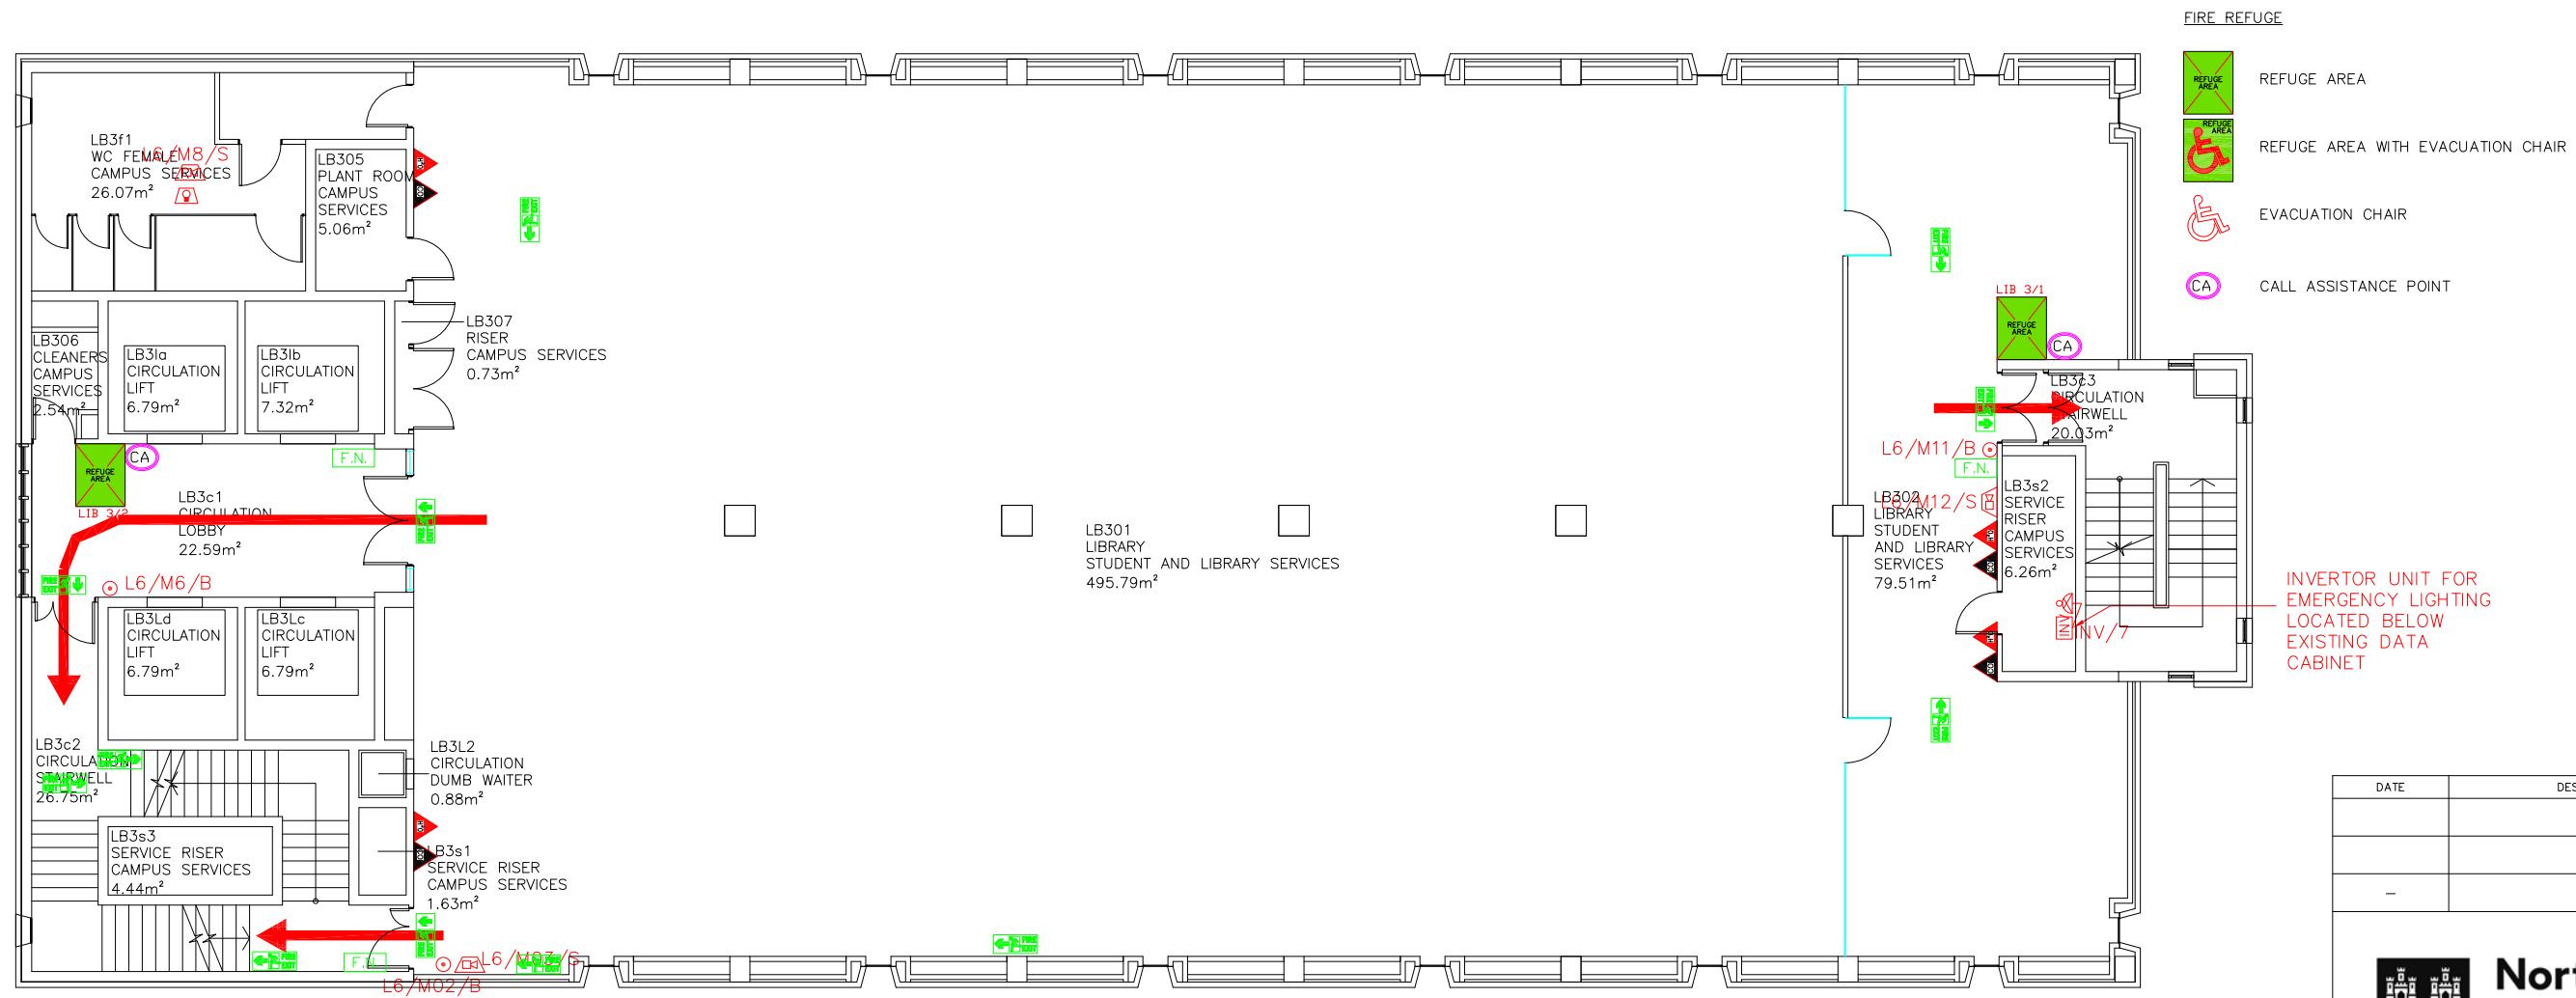

LIBRARY BUILDING
THIRD FLOOR PLAN
742.03m²

FIRE EQUIPMENT

- FIRE ALARM CALL POINT/BREAK GLASS
- FIRE ALARM CONTROL PANEL
- FIRE ALARM INTERFACE PANEL
- UNSWITCHED FUSE SPUR
- JUNCTION BOX
- FIRE ALARM SOUNDER
- FIRE ALARM BELL
- VISUAL WARNING DEVICE

FIRE EXTINGUISHERS

- WATER EXTINGUISHER
- CARBON DIOXIDE EXTINGUISHER
- FOAM EXTINGUISHER
- POWDER EXTINGUISHER
- FIRE BLANKET

FIRE SIGNAGE

- FIRE EXIT SIGN
- FIRE EXIT DIRECTIONAL SIGN
- DOUBLE SIDED FIRE EXIT SIGN
- FIRE ACTION NOTICE
- ILLUMINATED FIRE EXIT SIGN

FIRE REFUGE

- REFUGE AREA
- REFUGE AREA WITH EVACUATION CHAIR
- EVACUATION CHAIR
- CALL ASSISTANCE POINT

INVERTOR UNIT FOR
EMERGENCY LIGHTING
LOCATED BELOW
EXISTING DATA
CABINET

DATE	DESCRIPTION	REV
		-
		-
		-




Campus Services
Pandon Building
Camden Street
Newcastle upon Tyne
NE1 8ST

Campus: CITY CENTRE
Building: LIBRARY
Title: THIRD FLOOR LEVEL

Scale:	Date: JULY 2019
NTS	Drawn:
	Issued:

Project No:

Drawing No:	Rev:
-------------	------

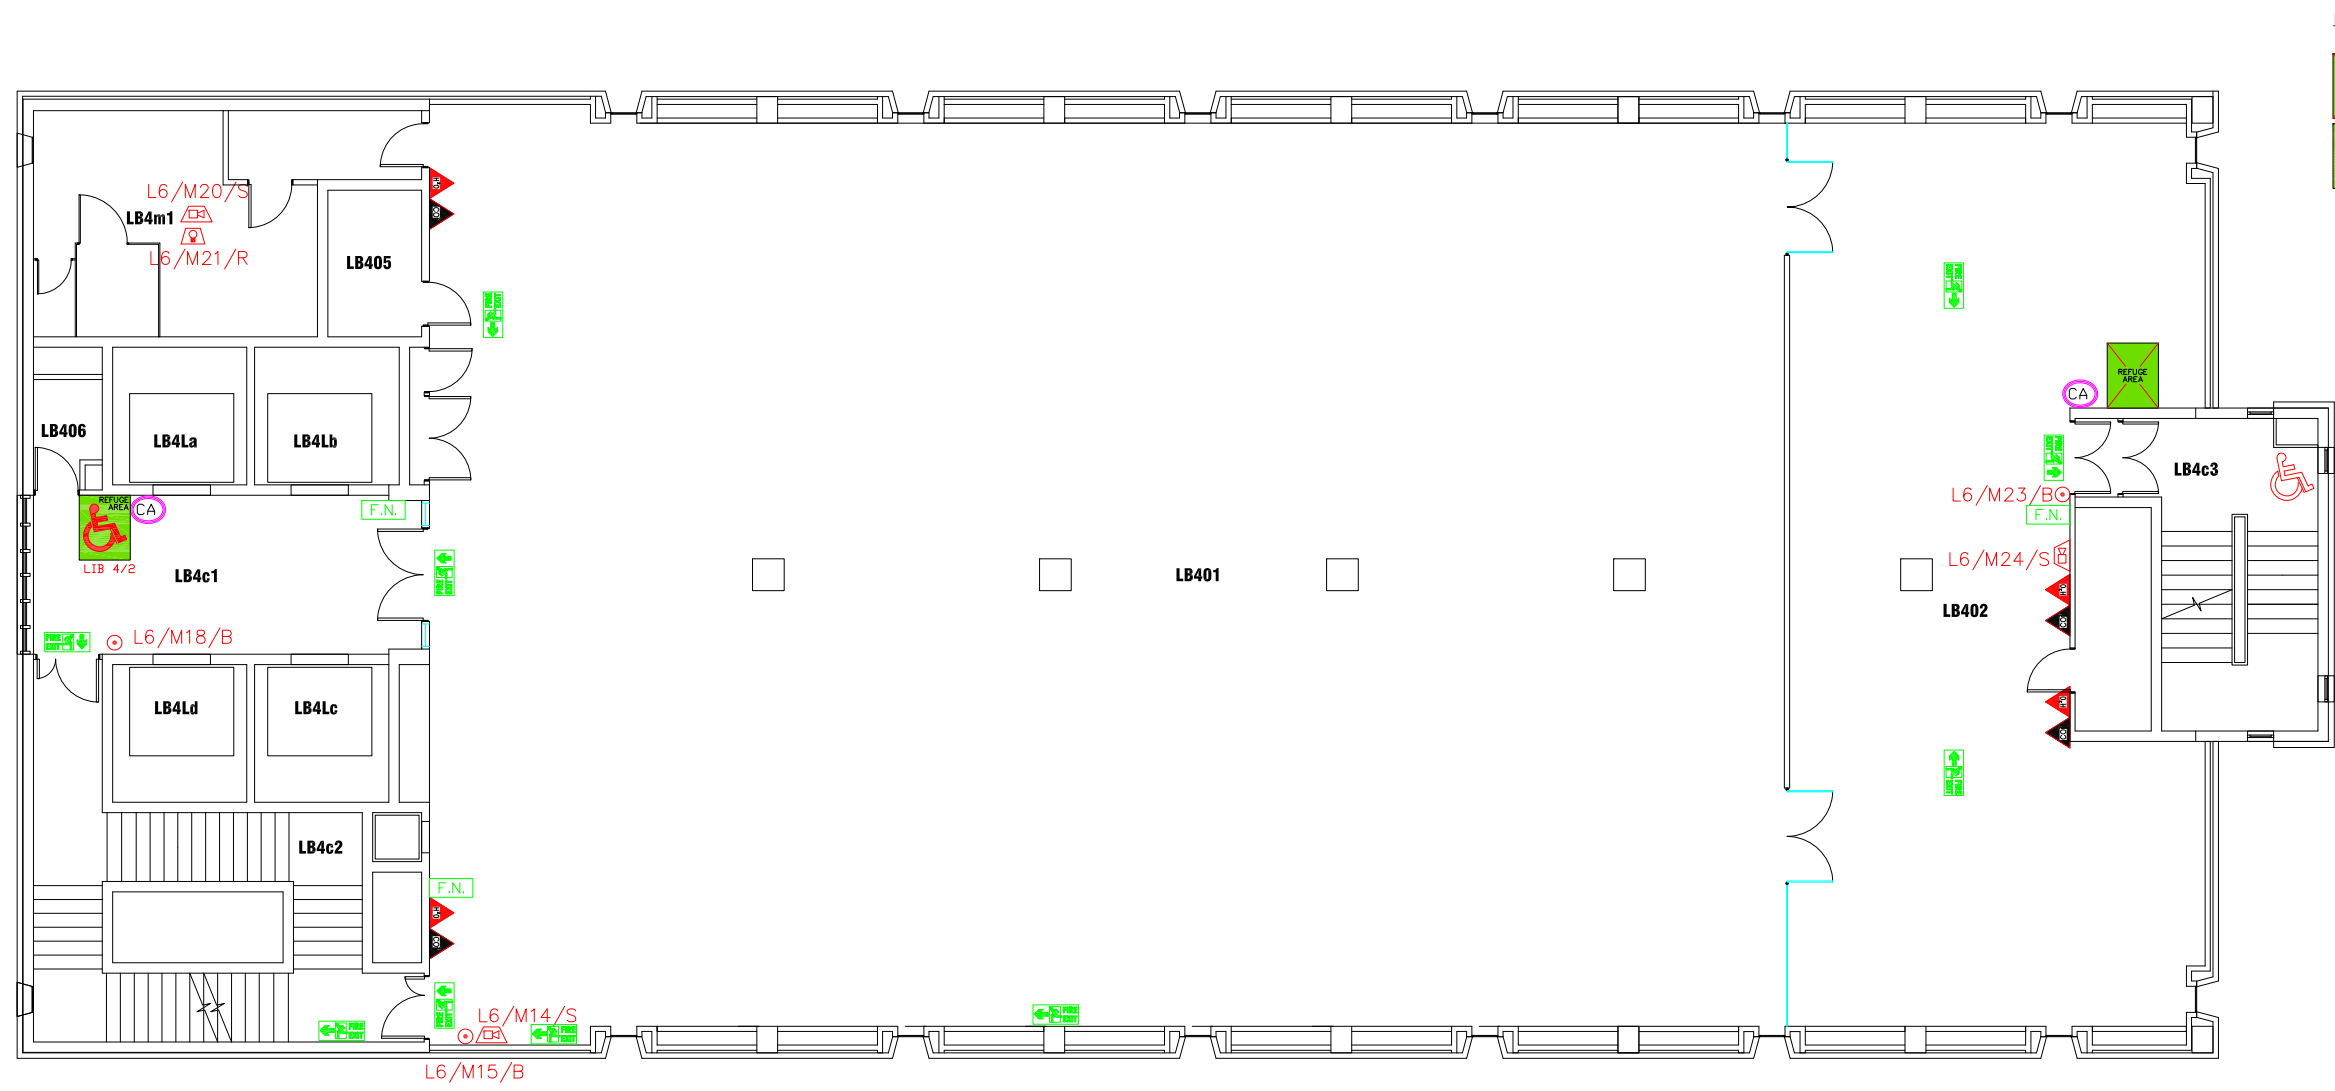

- FIRE REFUGE**
- REFUGE AREA
 - REFUGE AREA WITH EVACUATION CHAIR
 - EVACUATION CHAIR
 - CALL ASSISTANCE POINT

FIRE EQUIPMENT

- FIRE ALARM CALL POINT/BREAK GLASS
- FIRE ALARM CONTROL PANEL
- FIRE ALARM INTERFACE PANEL
- UNSWITCHED FUSE SPUR
- JUNCTION BOX
- FIRE ALARM SOUNDER
- FIRE ALARM BELL
- VISUAL WARNING DEVICE

FIRE EXTINGUISHERS

- WATER EXTINGUISHER
- CARBON DIOXIDE EXTINGUISHER
- FOAM EXTINGUISHER
- POWDER EXTINGUISHER
- FIRE BLANKET

FIRE SIGNAGE

- FIRE EXIT SIGN
- FIRE EXIT DIRECTIONAL SIGN
- DOUBLE SIDED FIRE EXIT SIGN
- FIRE ACTION NOTICE
- ILLUMINATED FIRE EXIT SIGN

DATE	DESCRIPTION	REV
		-
		-
-	-	-




Campus Services
Pandon Building
Camden Street
Newcastle upon Tyne
NE1 8ST

Campus: CITY CENTRE
Building: LIBRARY
Title: FOURTH FLOOR LEVEL

Scale:	Date: JULY 2019
NTS	Drawn:
	Issued:

Project No:

Drawing No:	Rev:
-------------	------

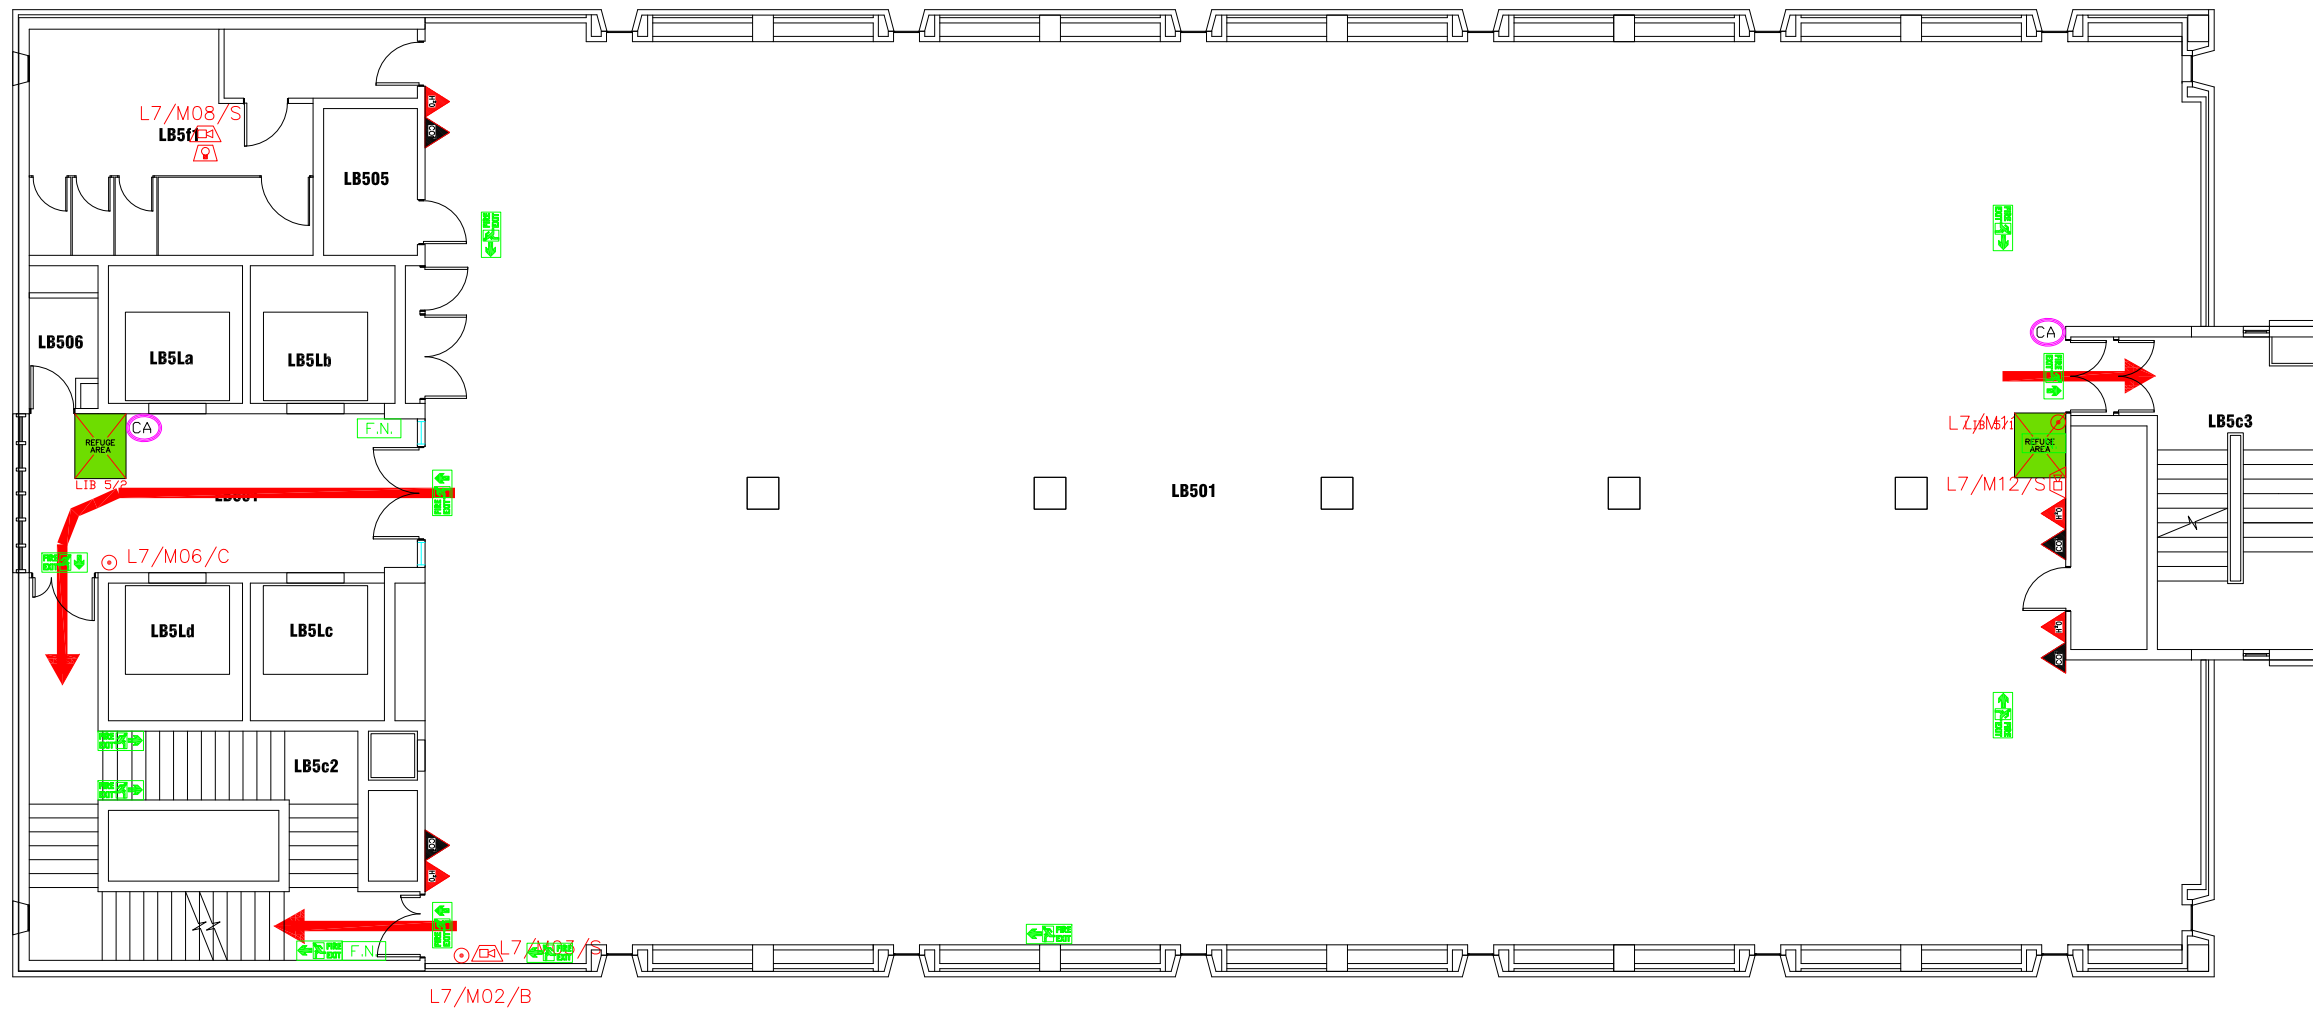

- FIRE EXTINGUISHERS**
- WATER EXTINGUISHER
 - CARBON DIOXIDE EXTINGUISHER
 - FOAM EXTINGUISHER
 - POWDER EXTINGUISHER
 - FIRE BLANKET
- FIRE SIGNAGE**
- FIRE EXIT SIGN
 - FIRE EXIT DIRECTIONAL SIGN
 - DOUBLE SIDED FIRE EXIT SIGN
 - F.N. FIRE ACTION NOTICE
 - ILLUMINATED FIRE EXIT SIGN

- FIRE EQUIPMENT**
- FIRE ALARM CALL POINT/BREAK GLASS
 - FACP FIRE ALARM CONTROL PANEL
 - INT FIRE ALARM INTERFACE PANEL
 - UNSWITCHED FUSE SPUR
 - JB JUNCTION BOX
 - FIRE ALARM SOUNDER
 - FIRE ALARM BELL
 - VISUAL WARNING DEVICE
- FIRE REFUGE**
- REFUGE AREA
 - REFUGE AREA WITH EVACUATION CHAIR
 - EVACUATION CHAIR
 - CA CALL ASSISTANCE POINT

DATE	DESCRIPTION	REV
		-
		-
-	-	-




Campus Services
Pandon Building
Camden Street
Newcastle upon Tyne
NE1 8ST

Campus: CITY CENTRE
Building: LIBRARY
Title: FIFTH FLOOR LEVEL





Scale:	Date: JULY 2019
NTS	Drawn:
	Issued:

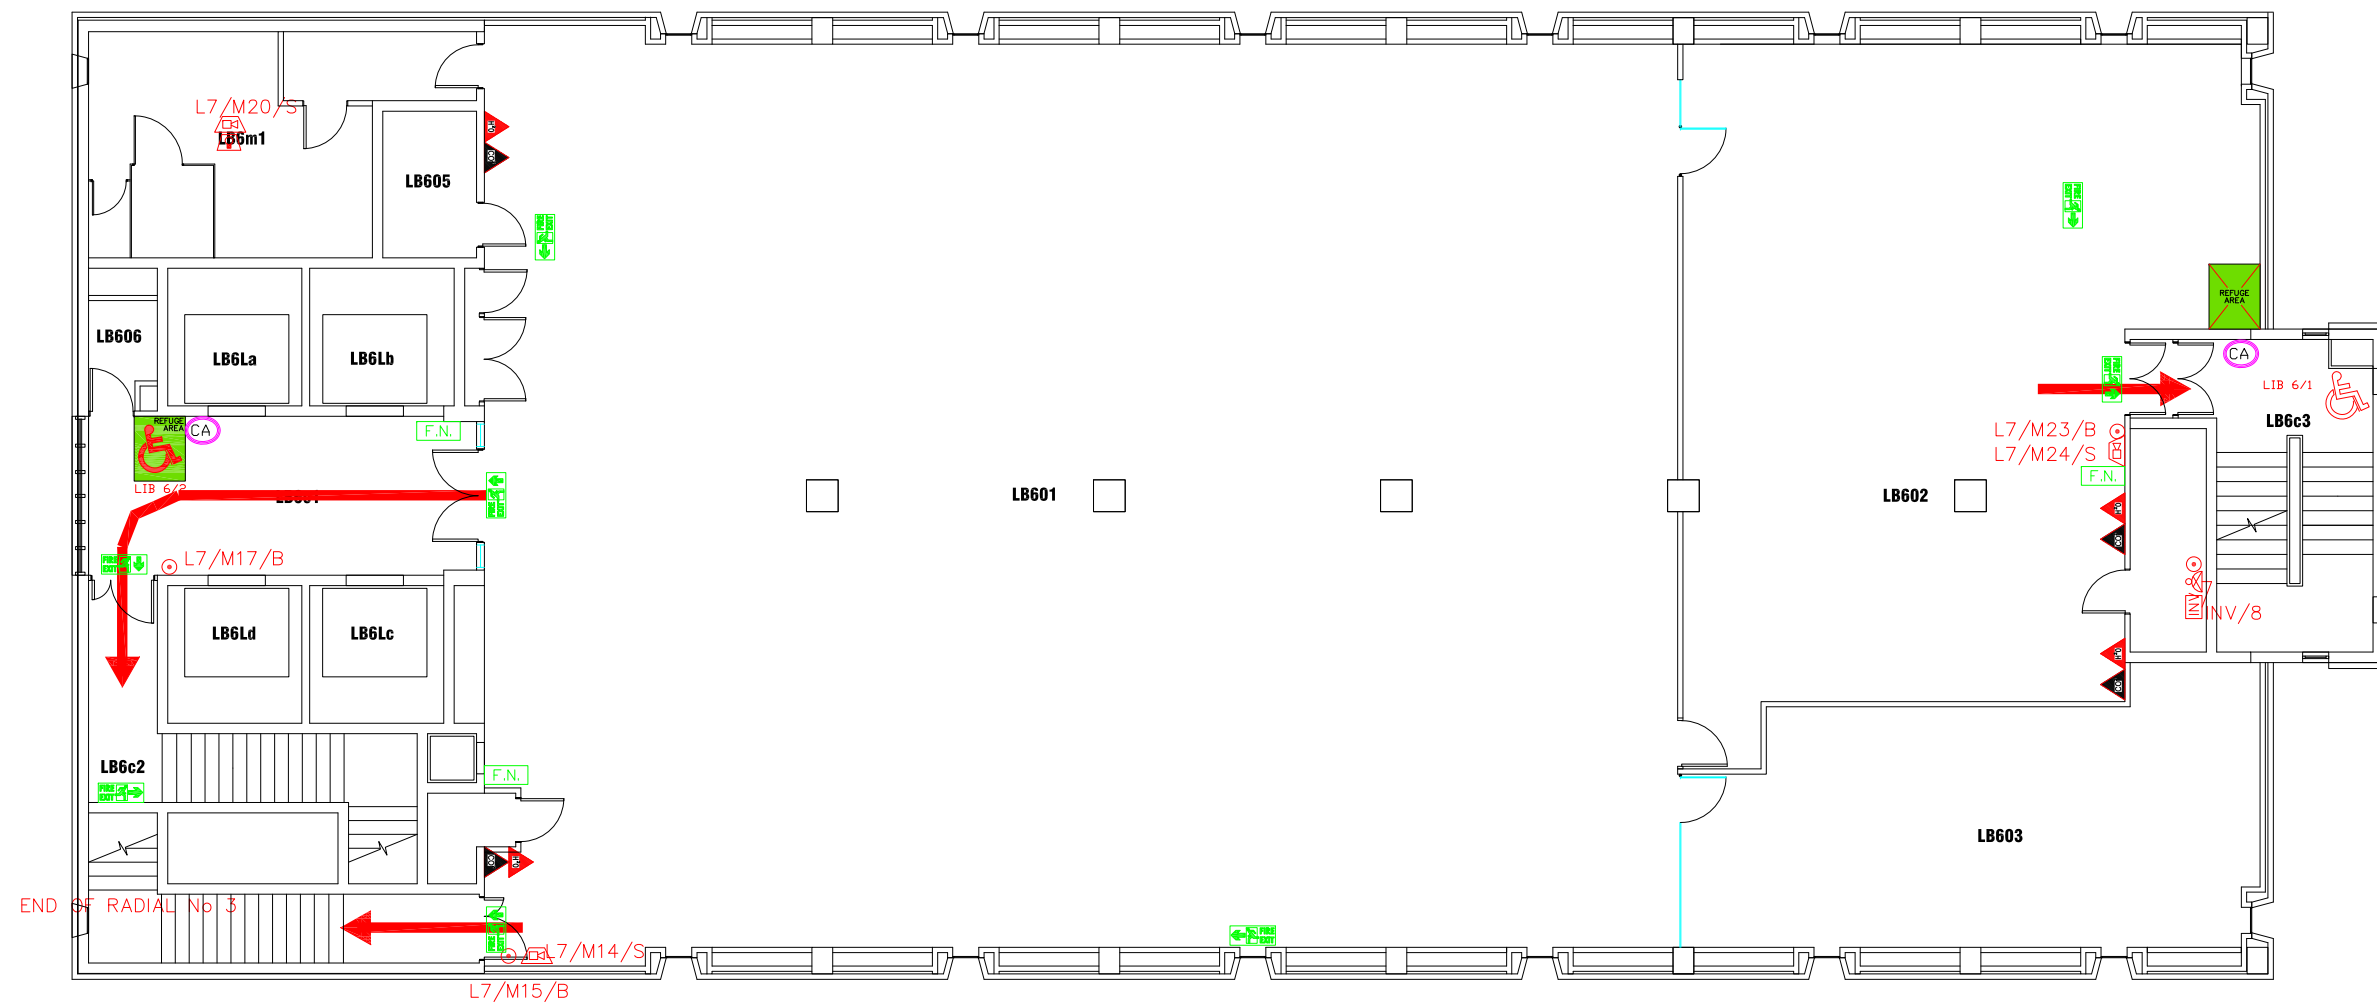Project No:

Drawing No: Rev:



FIRE REFUGE

-  REFUGE AREA
-  REFUGE AREA WITH EVACUATION CHAIR
-  EVACUATION CHAIR
-  CALL ASSISTANCE POINT

DATE	DESCRIPTION	REV
		-
		-
-	-	-



Campus Services
Pandon Building
Camden Street
Newcastle upon Tyne
NE1 8ST









Campus: CITY CENTRE
Building: LIBRARY
Title: SIXTH FLOOR LEVEL

Scale:	Date: JULY 2019
NTS	Drawn:
	Issued:






Project No:

Drawing No: Rev:






FIRE EQUIPMENT

-  FIRE ALARM CALL POINT/BREAK GLASS
-  FIRE ALARM CONTROL PANEL
-  FIRE ALARM INTERFACE PANEL
-  UNSWITCHED FUSE SPUR
-  JUNCTION BOX
-  FIRE ALARM SOUNDER
-  FIRE ALARM BELL
-  VISUAL WARNING DEVICE









FIRE EXTINGUISHERS

-  WATER EXTINGUISHER
-  CARBON DIOXIDE EXTINGUISHER
-  FOAM EXTINGUISHER
-  POWDER EXTINGUISHER
-  FIRE BLANKET






FIRE SIGNAGE

-  FIRE EXIT SIGN
-  FIRE EXIT DIRECTIONAL SIGN
-  DOUBLE SIDED FIRE EXIT SIGN
-  FIRE ACTION NOTICE
-  ILLUMINATED FIRE EXIT SIGN






FIRE EQUIPMENT


-  FIRE ALARM CALL POINT/BREAK GLASS
-  FIRE ALARM CONTROL PANEL
-  FIRE ALARM INTERFACE PANEL
-  UNSWITCHED FUSE SPUR
-  JUNCTION BOX
-  FIRE ALARM SOUNDER
-  FIRE ALARM BELL
-  VISUAL WARNING DEVICE

FIRE EXTINGUISHERS

-  WATER EXTINGUISHER
-  CARBON DIOXIDE EXTINGUISHER
-  FOAM EXTINGUISHER
-  POWDER EXTINGUISHER
-  FIRE BLANKET

FIRE SIGNAGE

-  FIRE EXIT SIGN
-  FIRE EXIT DIRECTIONAL SIGN
-  DOUBLE SIDED FIRE EXIT SIGN
-  FIRE ACTION NOTICE
-  ILLUMINATED FIRE EXIT SIGN

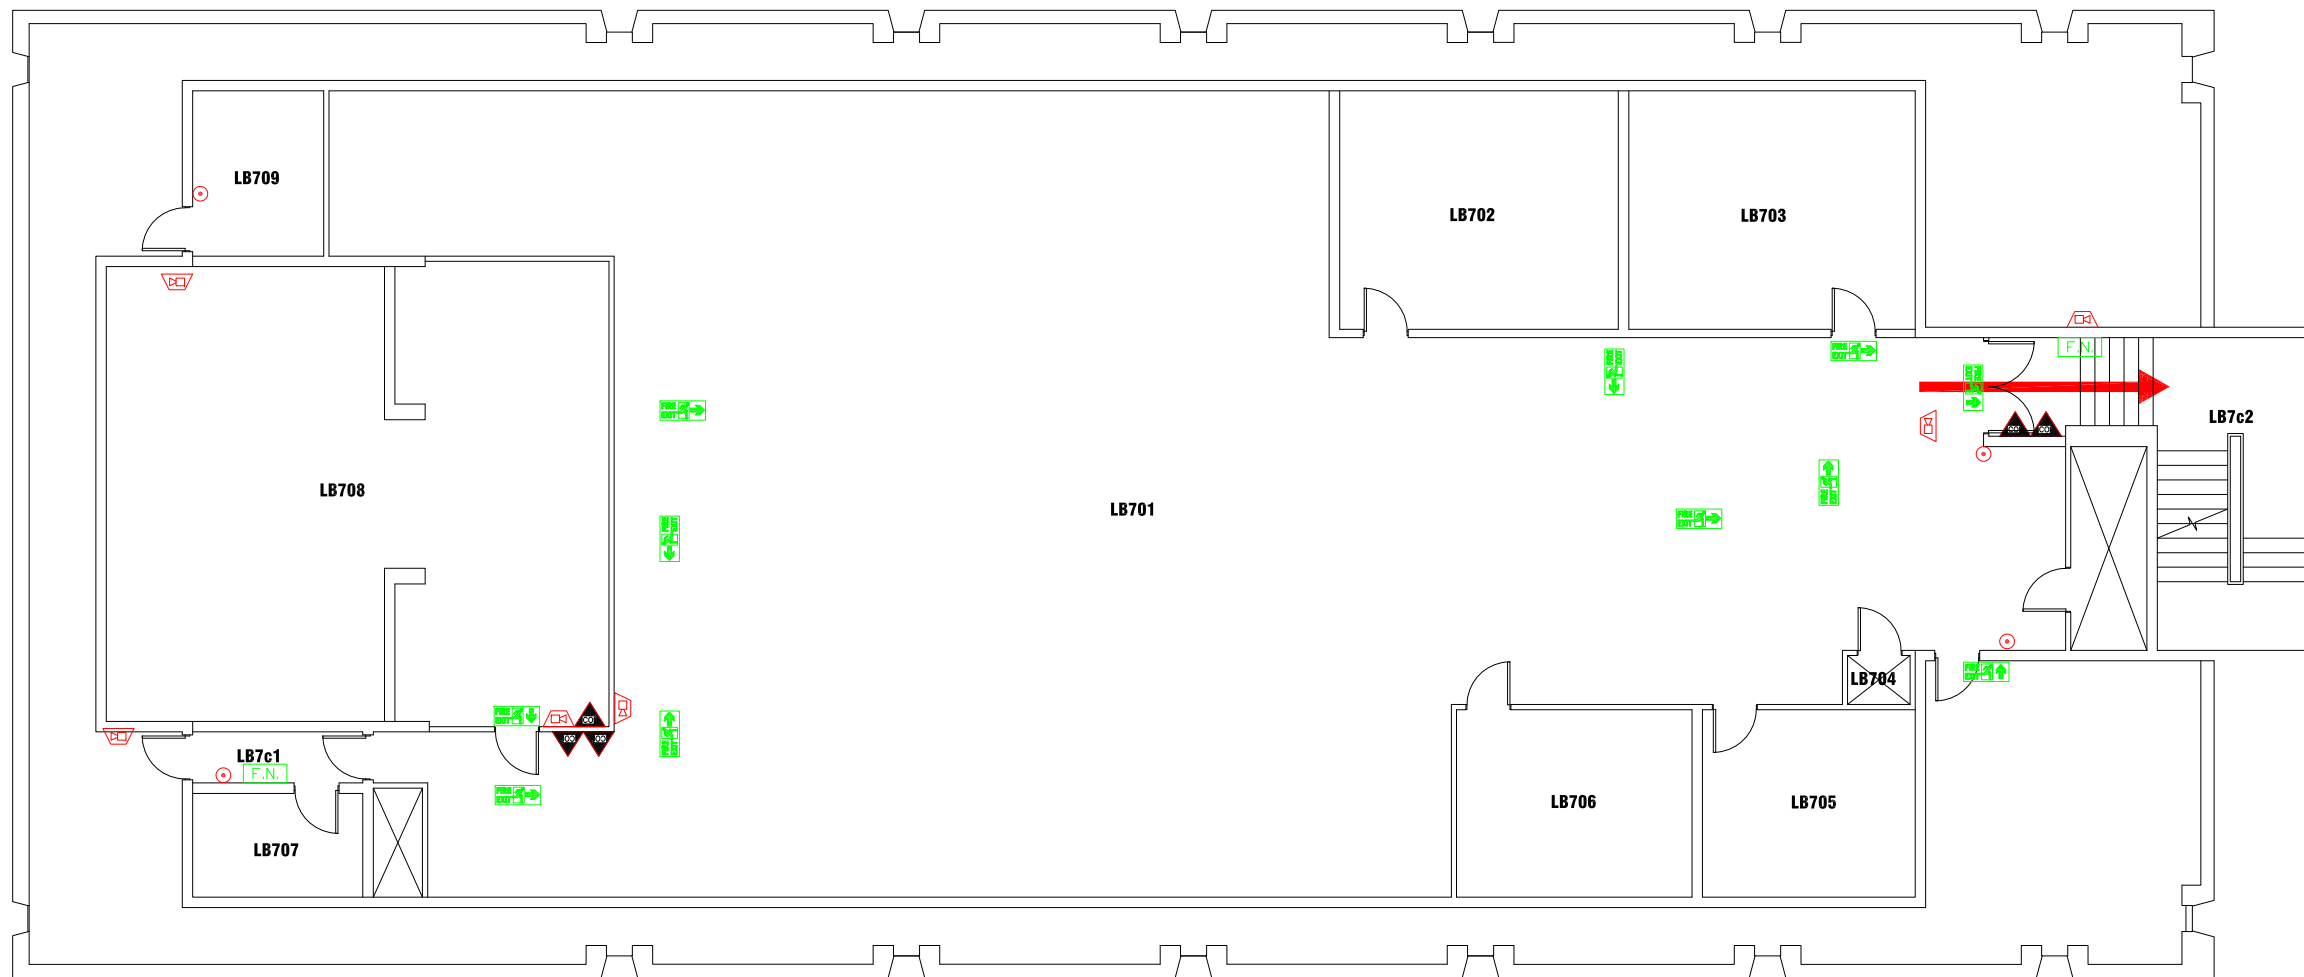

DATE	DESCRIPTION	REV
		-



Campus Services
 Pandon Building
 Camden Street
 Newcastle upon Tyne
 NE1 8ST

Campus: CITY CENTRE
 Building: LIBRARY
 Title: SEVENTH FLOOR LEVEL

Scale:	Date: JULY 2019
NTS	Drawn:
	Issued:

Project No:

Drawing No:	Rev:
-------------	------